


No. 1
 Issued for Site Plan Agreement

Date: March 23th 2023
 Drawn By: NJ
 Checked By: GP

Issue Date: March 23th 2023
 Scale: 1/32" = 1'-0"
 Sheet Number: E-1.0
 Project Number: 2022-69304

Symbol	Qty	Label	LLF	Lum. Lumens	Atr. Watts	Description
□	9	DSX2 LED P2 40K 70CRI TSM	0.950	26022	179.22	DSX2 LED P2 40K 70CRI TSM
□	6	DSX2 LED P4 40K 70CRI AFR	0.950	37389	272.65	DSX2 LED P4 40K 70CRI AFR
□	5	DSX2 LED P2 40K 70CRI BLC3	0.950	18125	179.22	DSX2 LED P2 40K 70CRI BLC3
□	2	DSX2 LED P1 40K 70CRI T4M	0.950	19769	134.5	DSX2 LED P1 40K 70CRI T4M
□	2	DSX2 LED P2 40K 70CRI TFTM	0.950	25469	179.22	DSX2 LED P2 40K 70CRI TFTM
□	3	WDGE3 LED P3 70CRI R4 40K	0.950	10360	71.6952	WDGE3 LED P3 70CRI R4 40K

Label	Units	Avg	Max	Min	Avg/Min	Max/Min
Front Parking Lot	Lux	45.58	293.8	0.5	91.16	587.60
Gated Parking Lot	Lux	17.42	32.4	4.2	4.15	7.71
Property Line	Lux	5.47	17.8	0.2	27.05	89.00
Rear Parking Lot	Lux	22.09	61.6	1.1	20.08	56.00

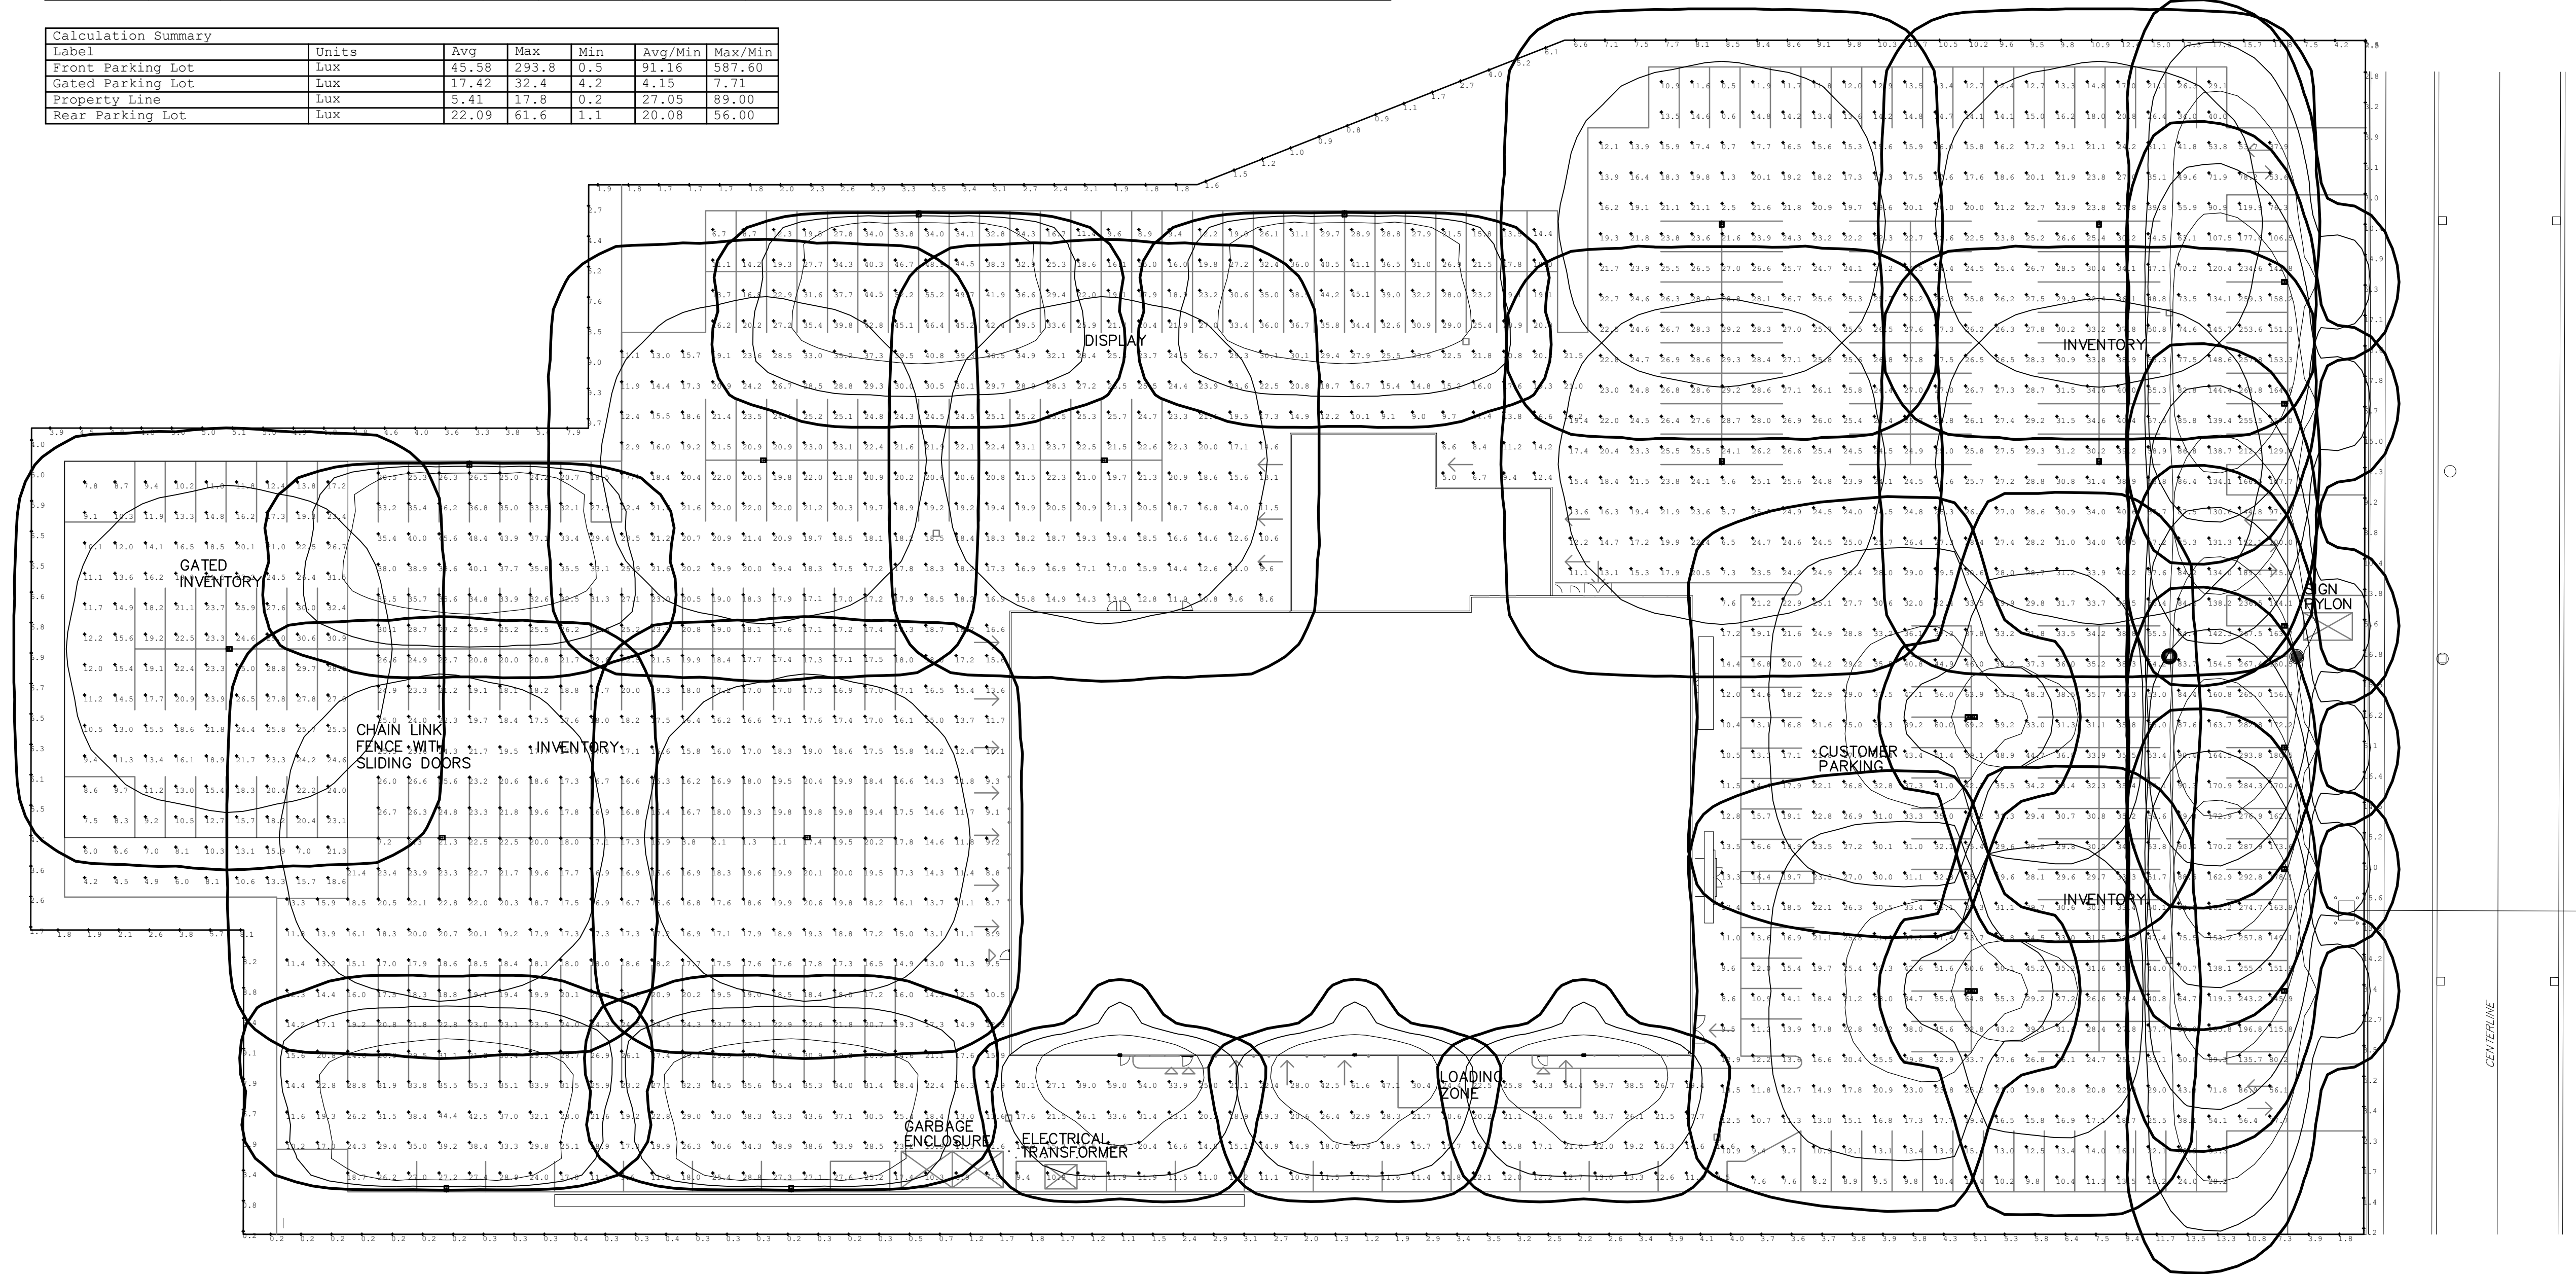

KING STREET